




SCALE 1 : 200

PLAN OF PROPOSED LAYOUT

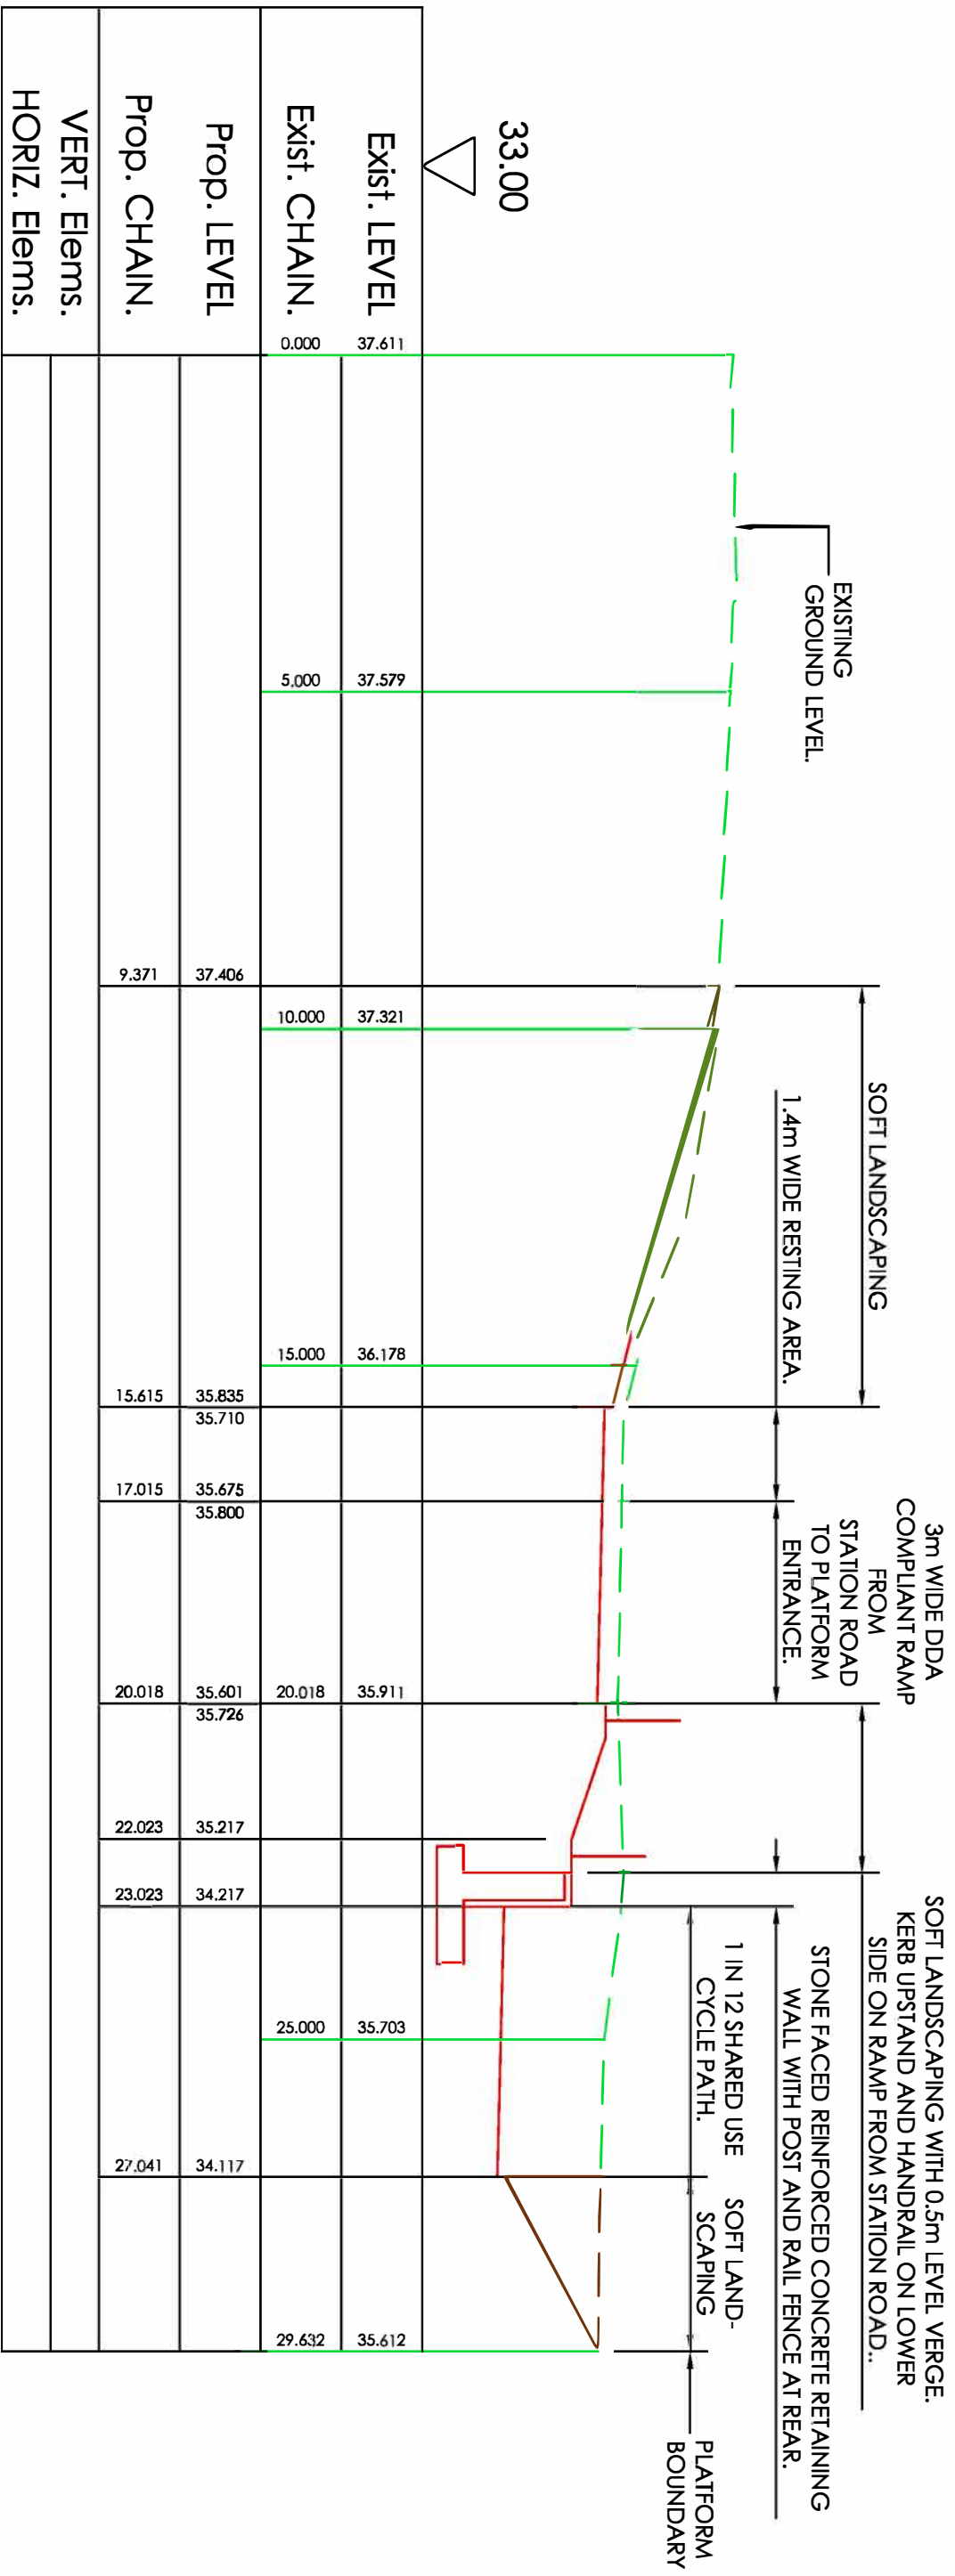

SECTION A-A TYPICAL CROSS SECTION

SCALE 1 : 100

KEY

- TREE RECOMMENDED FOR REMOVAL
- PROPOSED BOLLARD
- EXISTING LIGHTING COLUMN
- PROPOSED TREE: QUERCUS ROBUR, BETULA PENDULA, SORBUS AUCUPARIA, PRUNUS PADUS
- MEADOW GRASS IE. EMERGATE
- EMMIX
- SUDS RAINGARDEN PLANTING SWALE
- NATIVE SPRING BULBS
- NARCISSUS, GALANTHUS, HYACINTHOIDES, CROCUS
- NATIVE FLOWERING SHRUBS: ROSA PICHOTA, ALBA, ROSA RUGOSA, RUBRA, VIBURNUM OPULUS, ELONYMUS EUROPAEUS
- BIRD & BAT BOXES IN SUITABLE LOCATIONS AS ADVISED BY ECOLOGIST

Rev.	Description:	Date:
A	Tree planting updated with Adb report, lighting plans	11-11-2020
B	Tree planting updated	22-12-2020
C	Plan updated to show information on Access plan	13-4-2021

City Design Group

Place Shaping Team

Urban Design and Conservation Team

City Hall, College Green, Bristol BS1 5TR

www.bristol.gov.uk/citydesigngroup

Client:

Strategic City Transport

Project Title:

Ashley Down Station

Drawing Title:

Landscape Plan

Information Status:

PRELIMINARY

Drawn:

LE

Checked:

VW

Date:

9.07.20

Project No:

E17052 - 001

Scale:

1:200@A1

Dwg No:

0001

Revision:

C